


HEADER SCHEDULE

ALL EXT. HDRS. SHALL BE  
DBL 2X12 #2 H/F

INT. LOAD BRG. SHALL BE  
AS FOLLOWS:

- 0-3' DBL 2X6
- 3-6' DBL 2X6
- 6-8' DBL 2X8
- 8-10' DBL 2X10

INT. NON LOAD BRG. SHALL  
BE DBL 2X4'S

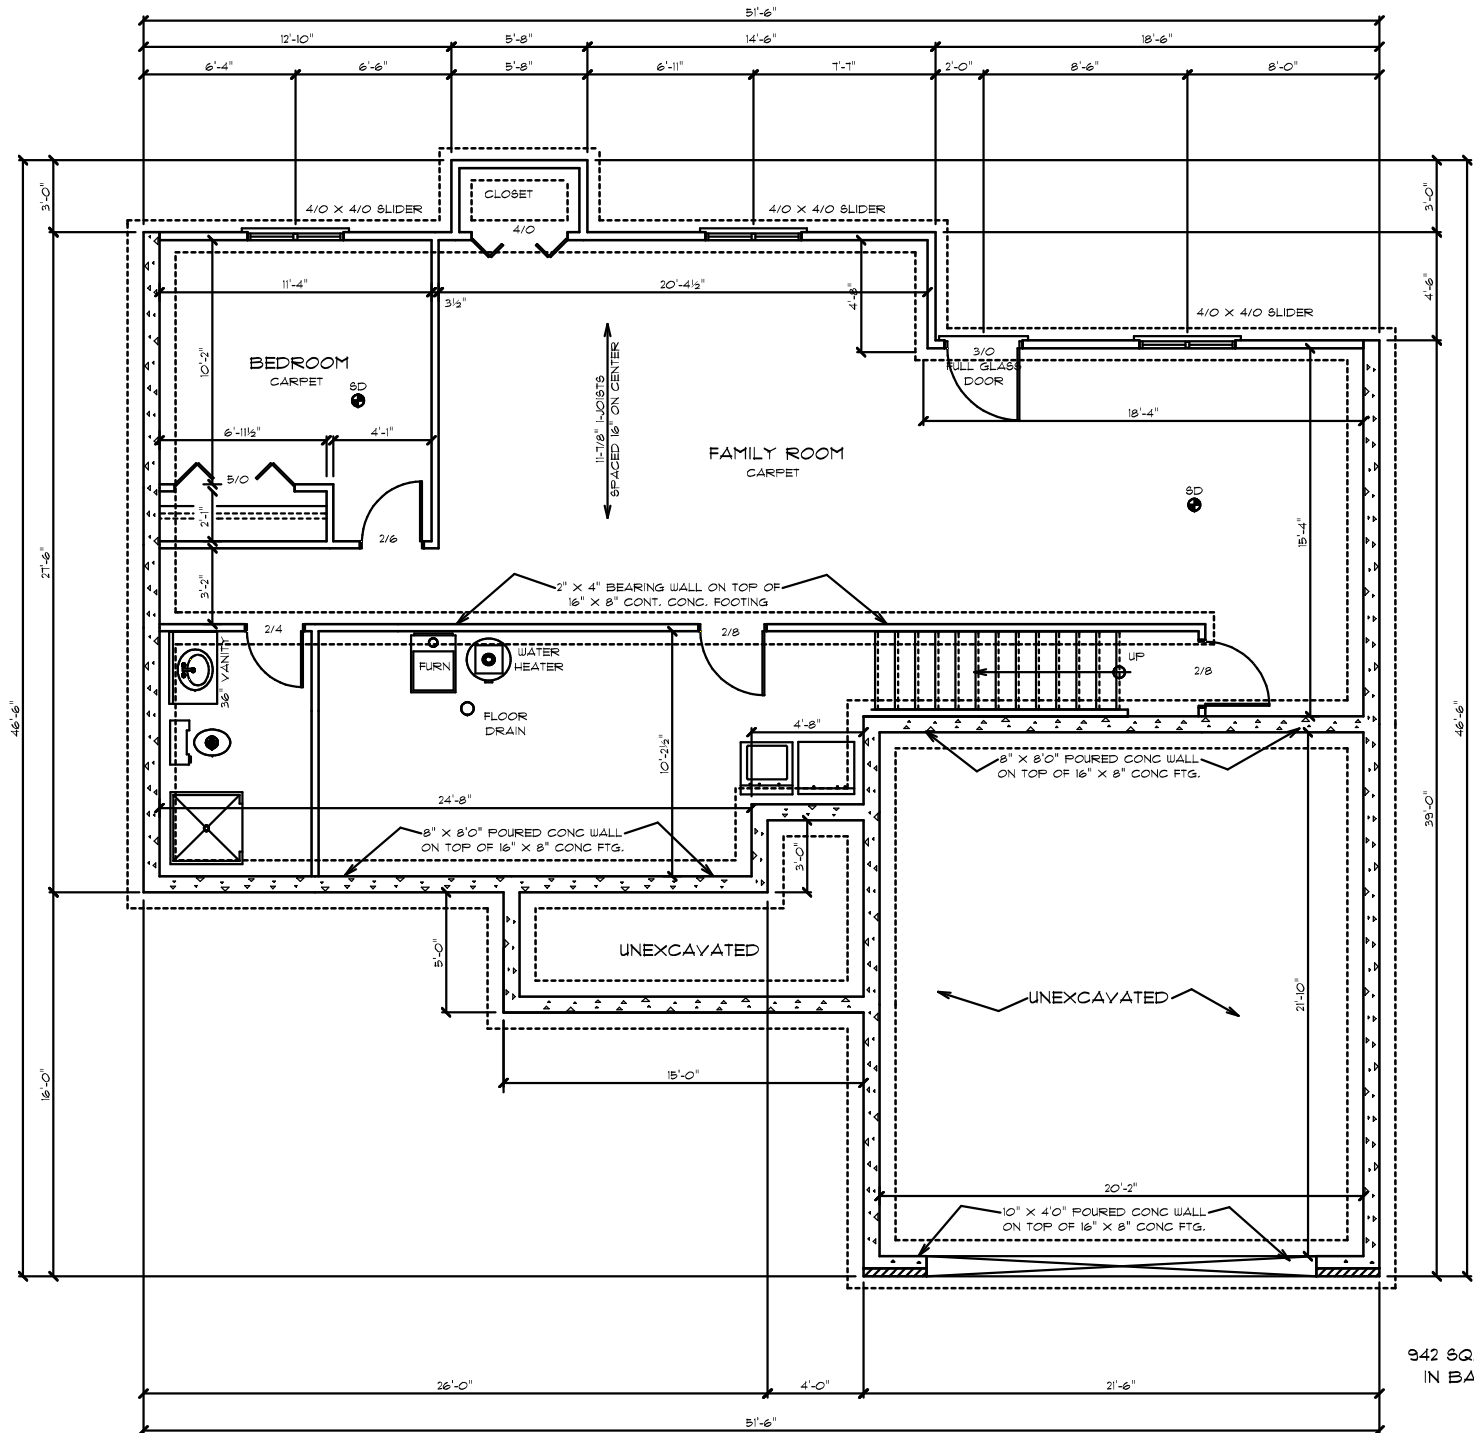

# FOUNDATION PLAN

CONTRACTOR VERIFY ALL DIMENSIONS

SCALE 1/4" = 1'-0"

942 SQ/FT FINISH  
IN BASEMENT

NOTE: GAS PIPING SERVICE IS NEEDED TO OPERATE GAS DRINKING  
FOUNTAIN. TO OPERATE THE WATER DISPENSATION FUNCTION, THE FOUNTAIN

JANUARY 2007